


RAWING NUMBER

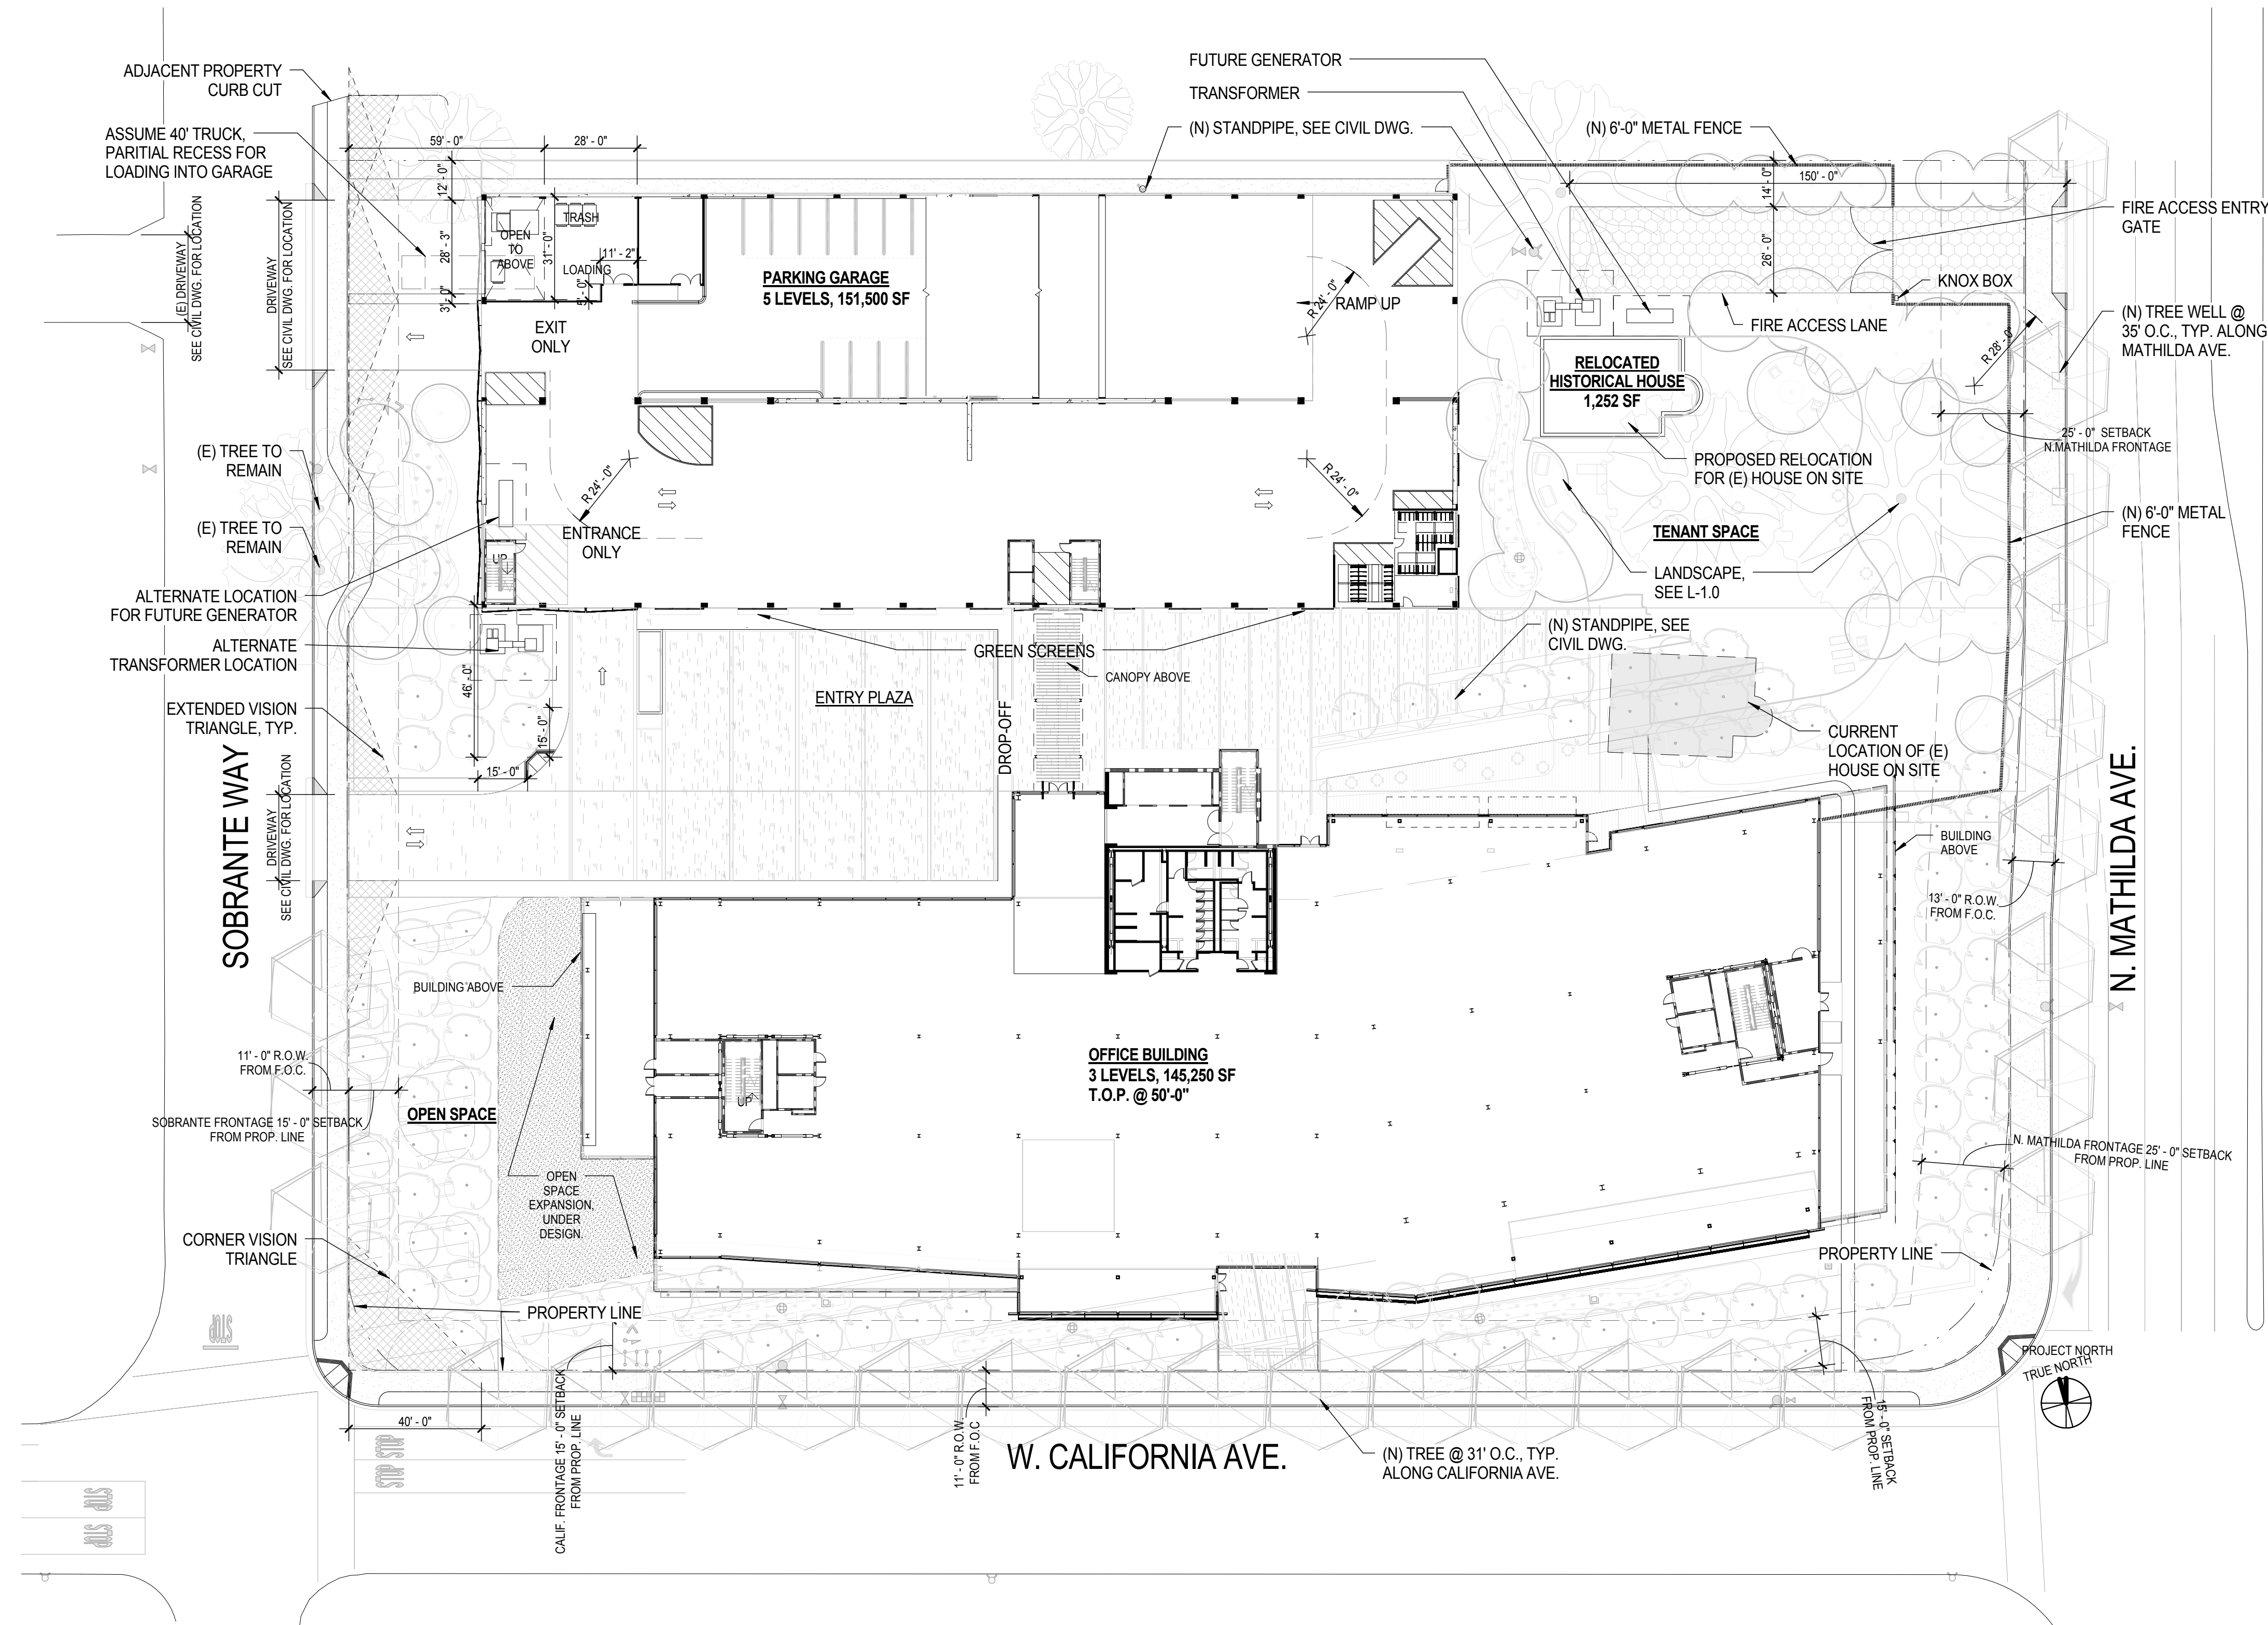

1 SITE PLAN (PRC)
SCALE: 1" = 30'-0"

[illegible]

NOT FOR
CONSTRUCTION

YPLAN

DRAWING TITLE


HISTORIC HOUSE PROPOSED PLAN

$$3'' = 1'-0''$$

15-7302	20316.000
TY PROJECT NUMBER	SGJJR PROJECT NUMBER

A201-H

DRAWING NUMBER

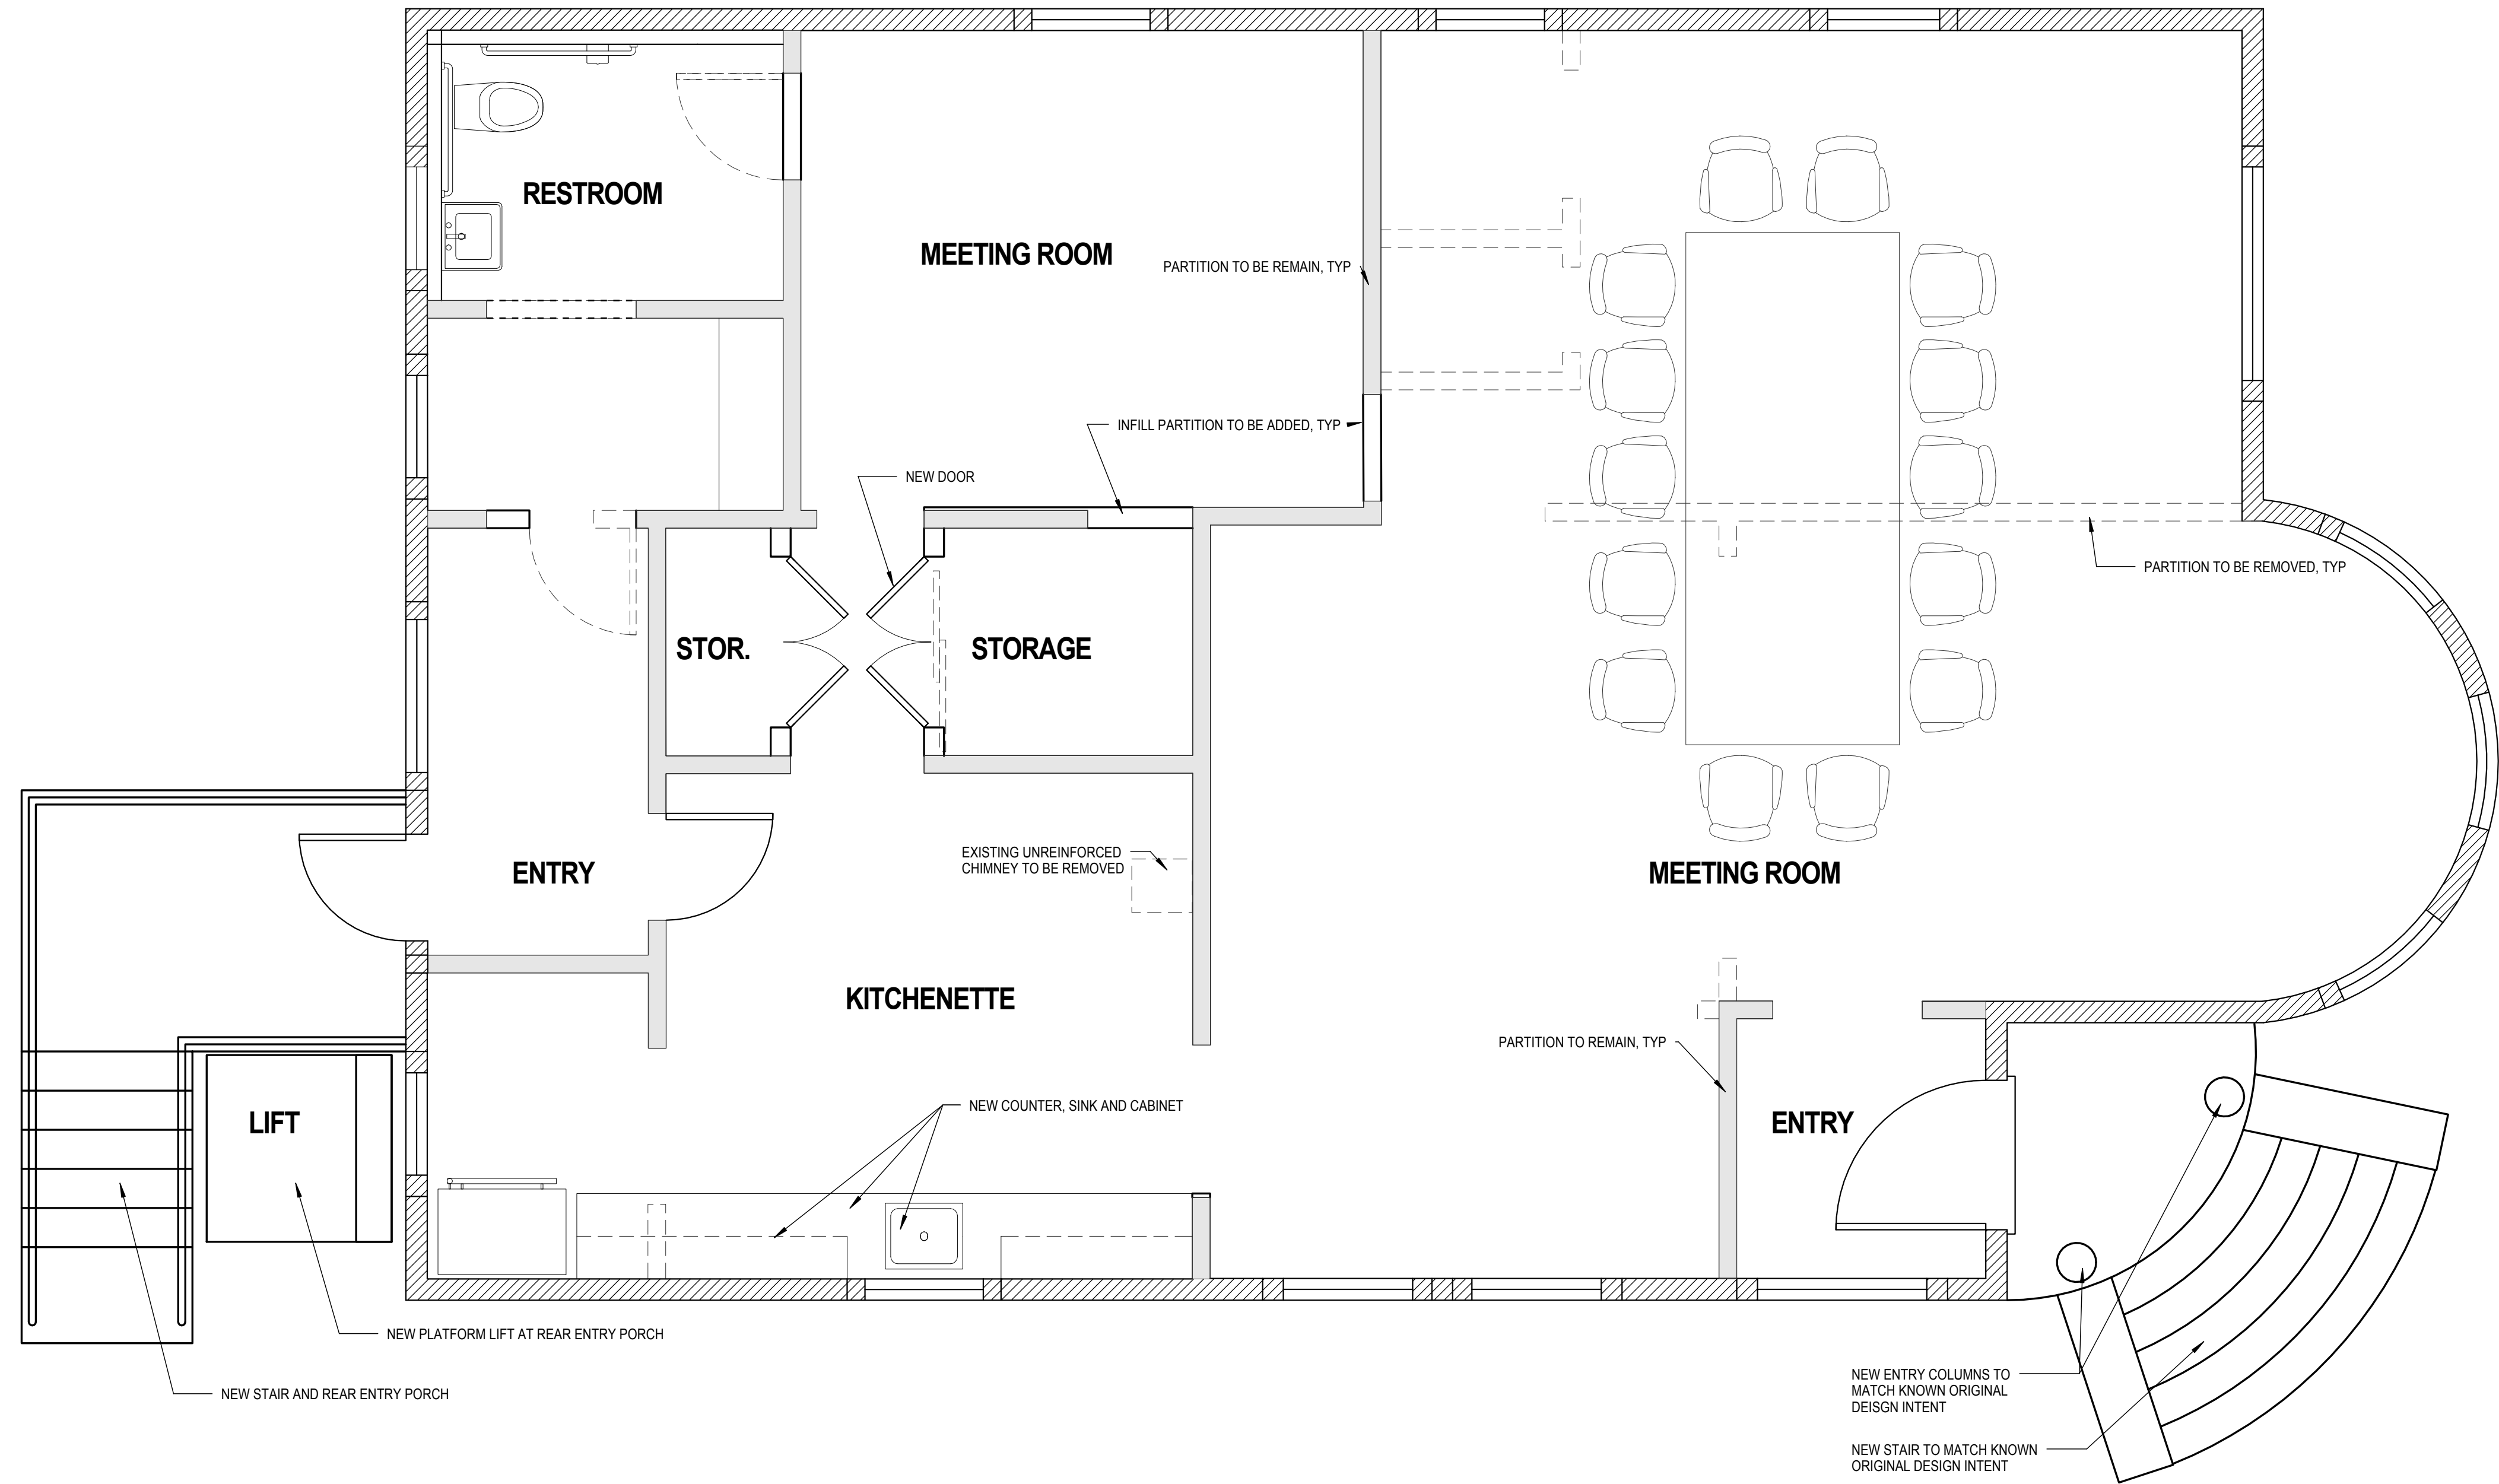

1 PROPOSED FLOOR PLAN
SCALE: 3/8" = 1'-0"

221 N. MATHILDA AVE

SUNNYVALE, CA 94086

SMITHGROUP JJR

301 BATTERY STREET
7TH FLOOR
SAN FRANCISCO, CA 94111
415.227.0100
www.smithgroupjjr.com

SMITHGROUP JJR
MECHANICAL, PLUMBING, ELECTRICAL & FIRE PROTECTION
1700 New York Avenue, NW, Suite 100
Washington, DC 20006
415.434.4664

Structural Engineers, Inc.
STRUCTURAL ENGINEER
2901 Tasman Drive, #100
Santa Clara, CA 95054
650.938.2200

MPA Design
LANDSCAPE ARCHITECT
414 Mason Street, Suite 700
San Francisco, CA 94102
415.434.4664

Kier & Wright Civil Engineers & Surveyors, Inc.
CIVIL ENGINEER
3350 Scott Boulevard, Building 22
Santa Clara, California 95054
408.727.6665

ISSUED FOR	REV	DATE

PLANNING SUB: RESTORATION PLAN12016-09-14

SEALS AND SIGNATURES

NOT FOR CONSTRUCTION

KEYPLAN

DRAWING TITLE

HISTORIC HOUSE
EAST ELEVATION

3/8" = 1'-0"


SCALE

2015-730220316.000

CITY PROJECT NUMBERSGJJR PROJECT NUMBER

A301-H

DRAWING NUMBER

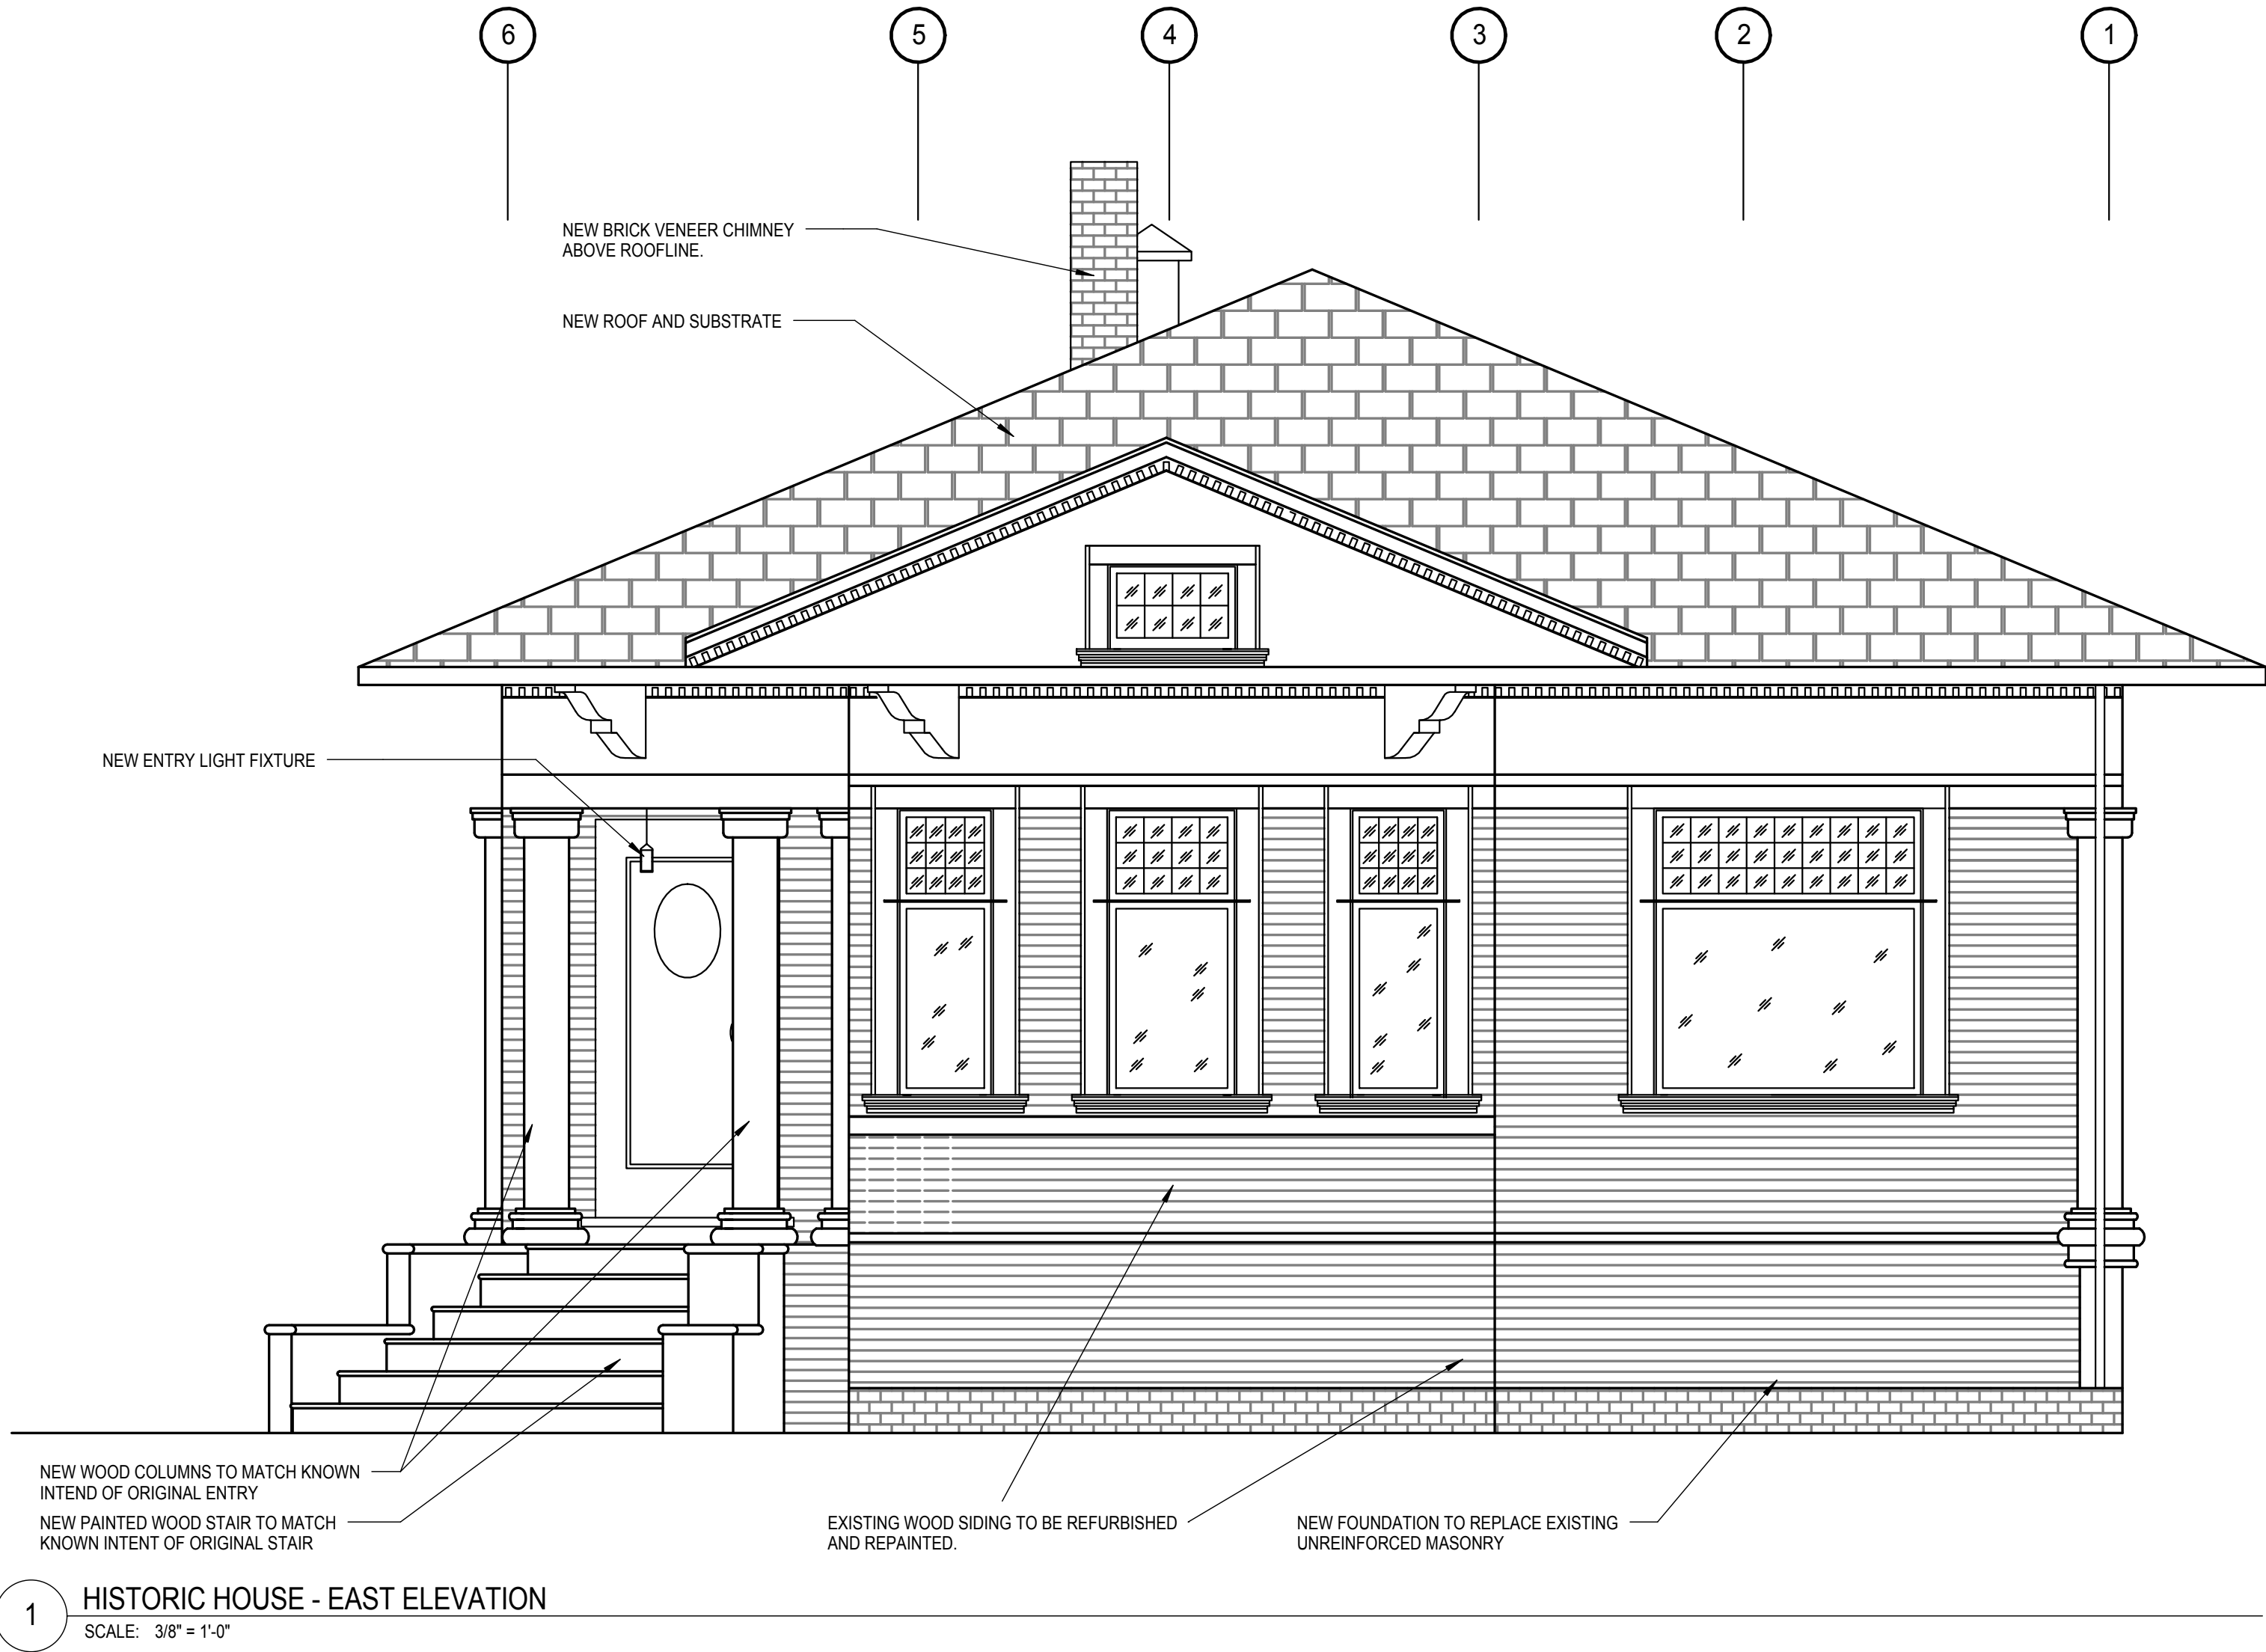

221 N. MATHILDA AVE

SUNNYVALE, CA 94086

SMITHGROUP JJR

301 BATTERY STREET
7TH FLOOR
SAN FRANCISCO, CA 94111
415.227.0100
www.smithgroupjir.com

SMITHGROUP JJR
MECHANICAL, PLUMBING, ELECTRICAL & FIRE PROTECTION
1700 New York Avenue, NW, Suite 100
Washington, DC 20006
415.434.4664

Structural Engineers, Inc.
STRUCTURAL ENGINEER
2901 Tasman Drive, #100
Santa Clara, CA 95054
650.938.2200

MPA Design
LANDSCAPE ARCHITECT
414 Mason Street, Suite 700
San Francisco, CA 94102
415.434.4664

Kier & Wright Civil Engineers & Surveyors, Inc.
CIVIL ENGINEER
3350 Scott Boulevard, Building 22
Santa Clara, California 95054
408.727.6665

ISSUED FOR	REV	DATE

PLANNING SUB. RESTORATION PLAN12016-09-14

SEALS AND SIGNATURES

NOT FOR
CONSTRUCTION

KEYPLAN

DRAWING TITLE

HISTORIC HOUSE
SOUTH
ELEVATION

SCALE

3/8" = 1'-0"

2015-730220316.000
CITY PROJECT NUMBERSGJJR PROJECT NUMBER

A302-H

DRAWING NUMBER

