

VICINITY MAP N.T.S.

COMMERCIAL T.I

595 E EL CAMINO REAL
SUNNYVALE, CALIFORNIA 94087
BLOCK/LOT: 211.01.039

ICE DESIGN INC.
1000 N. RAVENHILL AVENUE
SUITE 100
SUNNYVALE, CA 94087
TEL: 650.741.6666
WWW.ICEDESIGNINC.COM

INNOVATIVE CONSULTING ENGINEER

APPLICATOR:

ALFO ON KOREA, LLC

595 E EL CAMINO REAL
SUNNYVALE, CA 94087

213.222.7413

SHEET TITLE:

COLOR SHEET
SITE PLAN &
GENERAL NOTES

PROJECT ADDRESS:
595 E EL CAMINO REAL
SUNNYVALE, CA 94087
APN: 211.01.039

PROJECT DESCRIPTION:
COMMERCIAL T.I.

PREPARED BY: TIEN CHAI
REVIEWED BY: JEFF CHOW
PHONE #: 650.741.6666

NOTES	BY
△ 03072017 COMMENT T.C.	T.C.
△ 04072017 COMMENT T.C.	T.C.
△ 04212017 COMMENT T.C.	T.C.
△ 05122017 REVISION T.C.	T.C.
△	
△	
DATE 11/2/2016	
SCALE AS NOTED	
DRAWN T.C.	
X-B 161002	
SHEET	

A0.1
OF
SHEETS


PRINT DATE: Nov 08, 2017 - 2:34pm

- ### LIST OF DRAWINGS

 - AD 1.0 COVER SHEET, SITE PLAN & GENERAL NOTES
 - AD 1.1 SITE PLAN
 - AD 1.2 AS BUILT FLOOR PLAN
 - AD 1.3 ADA ACCESSIBLE PARKING
 - AD 1.4 ADA ACCESSIBLE SIGN
 - AD 1.5 ACCESSIBILITY NOTE
 - AD 1.6 FINISH PLAN
 - AD 1.7 WINDOW AND DOOR SCHEDULE
 - AD 1.8 EXTERIOR ELEVATIONS
 - AD 1.9 REFLECTED CEILING PLAN
 - AD 2.0 EXTERIOR ELEVATIONS
 - AD 2.1 EXTERIOR ELEVATIONS
 - AD 2.2 EXTERIOR ELEVATIONS
 - AD 2.3 EXTERIOR ELEVATIONS
 - AD 2.4 EXTERIOR ELEVATIONS
 - AD 2.5 EXTERIOR ELEVATIONS
 - AD 2.6 EXTERIOR ELEVATIONS
 - AD 2.7 EXTERIOR ELEVATIONS
 - AD 2.8 EXTERIOR ELEVATIONS
 - AD 2.9 EXTERIOR ELEVATIONS
 - AD 2.10 EXTERIOR ELEVATIONS
 - AD 2.11 EXTERIOR ELEVATIONS
 - AD 2.12 EXTERIOR ELEVATIONS
 - AD 3.00 EXTERIOR ELEVATIONS
- ### PROJECT INFORMATION AND GENERAL NOTES

 - FS-1 PROJECT INFORMATION AND GENERAL NOTES
 - FS-2 PROJECT INFORMATION AND GENERAL NOTES
 - FS-3 PROJECT INFORMATION AND GENERAL NOTES
 - FS-100 PROJECT INFORMATION AND GENERAL NOTES
- ### LEGEND, NOTES & SCHEDULES

 - EQ 1 LEGEND, NOTES & SCHEDULES
 - EQ 2 LEGEND, NOTES & SCHEDULES
 - EQ 3 LEGEND, NOTES & SCHEDULES
 - EQ 100 LEGEND, NOTES & SCHEDULES

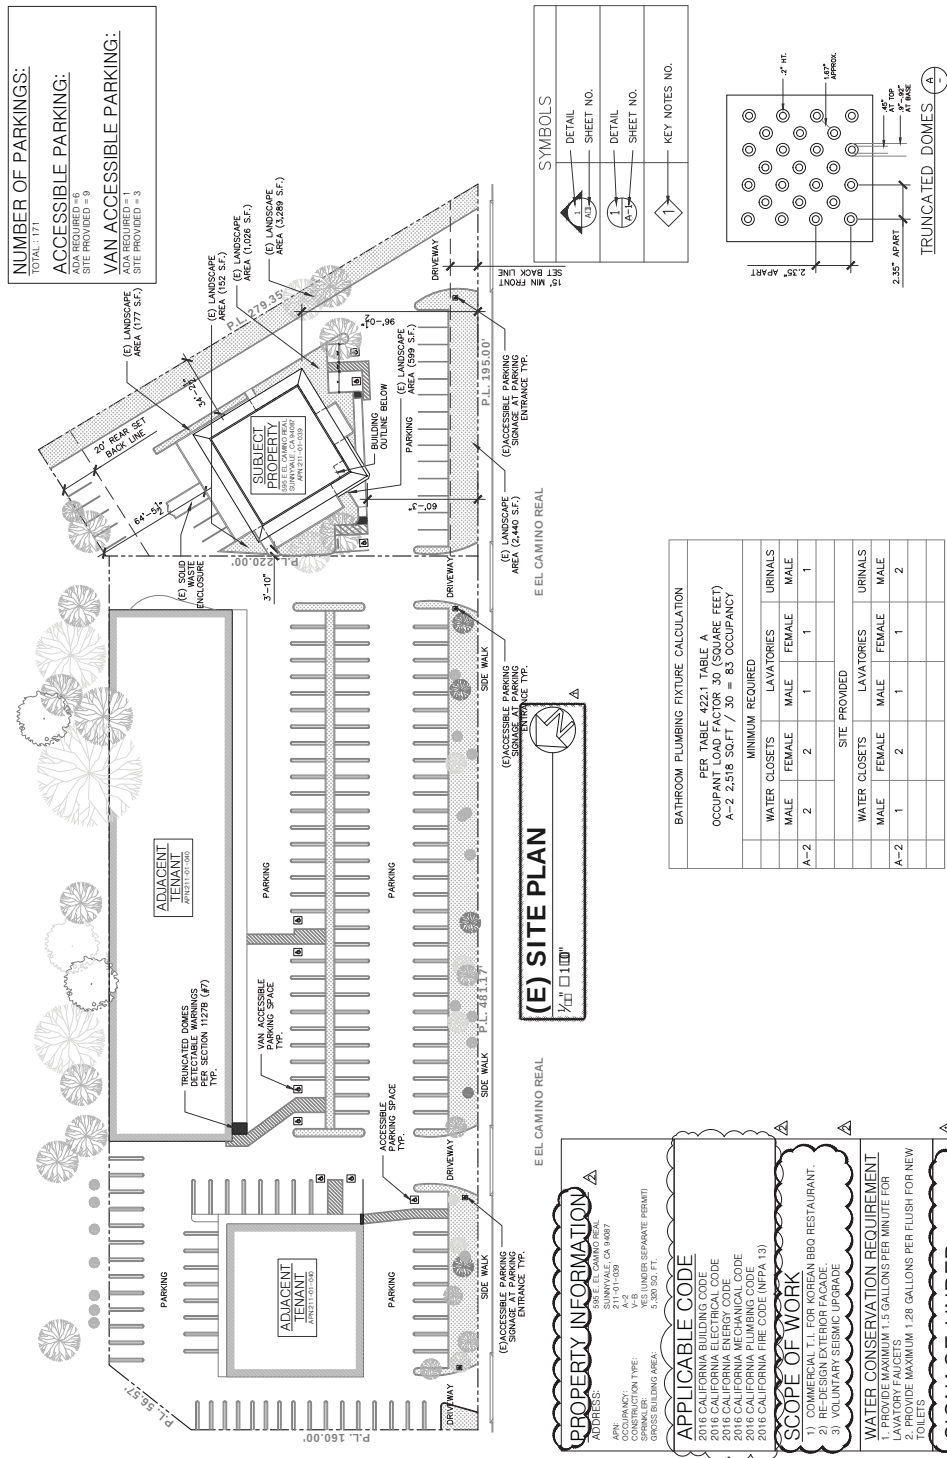

(E) SITE PLAN

BATHROOM PLUMBING FIXTURE CALCULATION											
PER TABLE 402.1 TABLE A											
OCCUPANT LOAD FACTOR 30 (SQUARE FEET)											
A-2 2,518 SQ.FT / 30 = 83 OCCUPANCY											
MINIMUM REQUIRED						SITE PROVIDED					
WATER CLOSETS		LAVATORIES		URINALS		WATER CLOSETS		LAVATORIES		URINALS	
MALE	FEMALE	MALE	FEMALE	MALE	FEMALE	MALE	FEMALE	MALE	FEMALE	MALE	FEMALE
A-2	2	2	1	1	1						
WATER CLOSETS		LAVATORIES		URINALS		WATER CLOSETS		LAVATORIES		URINALS	
MALE	FEMALE	MALE	FEMALE	MALE	FEMALE	MALE	FEMALE	MALE	FEMALE	MALE	FEMALE
A-2	1	2	1	1	1	2					

PROPERTY INFORMATION

ADDRESS: 595 E EL CAMINO REAL
APN: 211.01.039
CONTRACTOR: T.C. CHOW
CONSTRUCTION TYPE: V-B
PERMIT: 211-01-039-001
GROSS BUILDING AREA: 5,300 SQ. FT.

APPLICABLE CODE

2016 CALIFORNIA BUILDING CODE
2016 CALIFORNIA ELECTRICAL CODE
2016 CALIFORNIA ENERGY CODE
2016 CALIFORNIA FIRE CODE
2016 CALIFORNIA PLUMBING CODE
2016 CALIFORNIA FIRE CODE (NFPA 13)


SCOPE OF WORK

1) COMMERCIAL T.I. FOR KOREAN BBQ RESTAURANT.
2) RE-DESIGN EXTERIOR FACADE.
3) VOLUNTARY SEISMIC UPGRADE.

WATER CONSERVATION REQUIREMENT

1. PROVIDE MAXIMUM 1.5 GALLONS PER MINUTE FOR EACH TOILET
2. PROVIDE MAXIMUM 1.28 GALLONS PER FLUSH FOR NEW TOILETS

SIGNAGE UNDER SEPARATE SIGN PERMIT

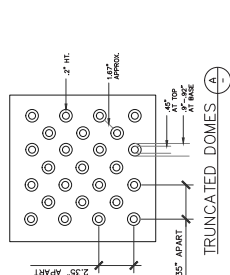



**INNOVATIVE
CONSULTING
ENGINEER**

30 South Spence Ave #10
S. San Francisco, CA 94003
(650) 741-6966
info@ic-engineering.com

ALLFO ON KOREA, LLC
595 E EL CAMINO REAL
SUNNYVALE, CA 94087
213.222.7413

SHEET TITLE:

SITE PLANS

PROJECT ADDRESS:
595 E EL CAMINO REAL
SUNNYVALE, CA 94087
APN: 211.01.039

PROJECT DESCRIPTION:
COMMERCIAL T.I.

PREPARED BY : TIEN CHU
REVIEWED BY : JEFF CHOW
PHONE # : 650.741.6968

NOTES	BY
△ 03072017COMMENT	T.C.
△ 04072017COMMENT	T.C.
△ 04212017COMMENT	T.C.
△ 05122017REVISION	T.C.
△	
△	


DATE	11/2/2016
SCALE	AS NOTED
DRAWN	T.C.
JOB	161002
SHEET	


A0.1 ☐ OF ☐ SHEETS

PRINT DATE: Nov 25, 2017 - 12:11pm

LOT COVERAGE CALCULATION

LOT AREA	=	30,177 S.F.
MAX. LOT COVERAGE	=	35% (10,562 S.F./30,177 S.F.)
(E) LOT COVERAGE	=	20% (6,058 S.F./30,177 S.F.)
(P) LOT COVERAGE	=	20% (6,058 S.F./30,177 S.F.)

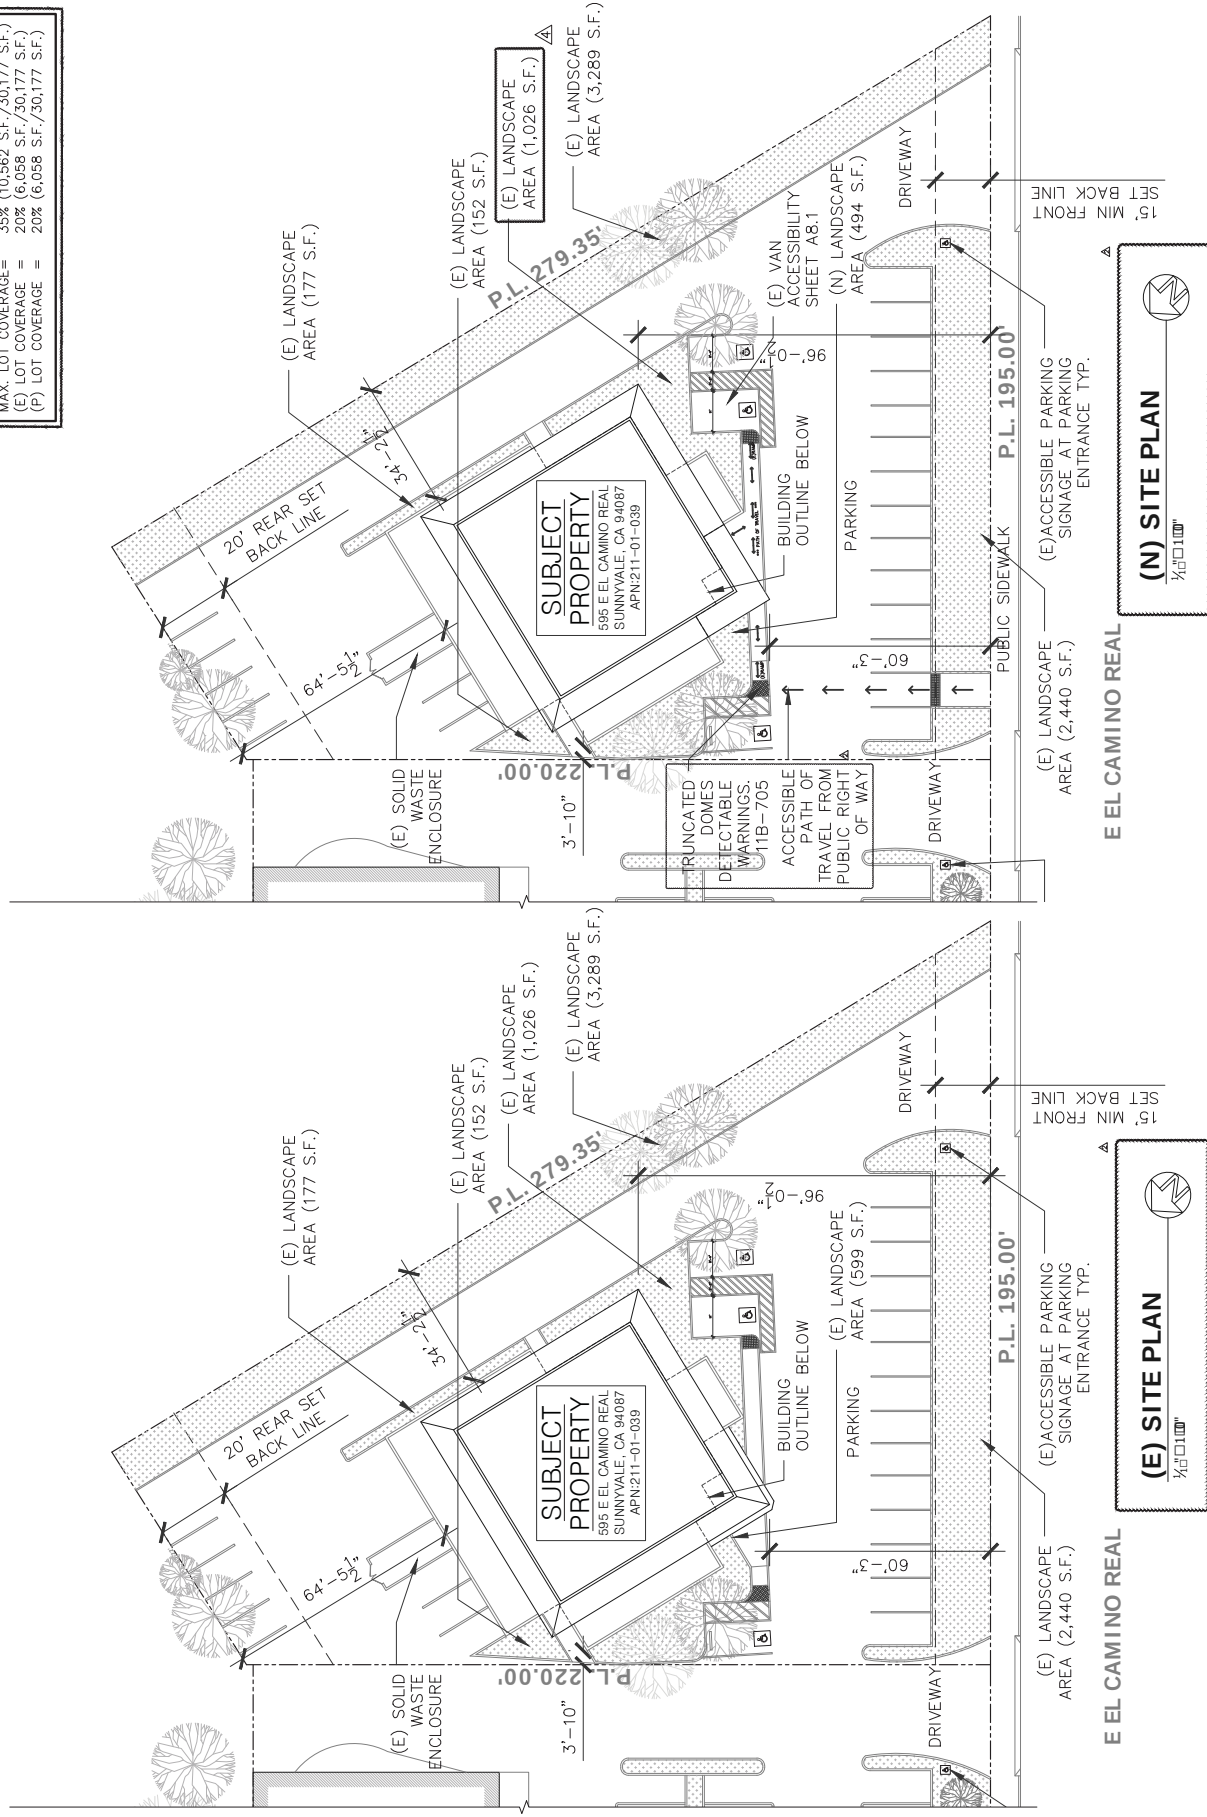

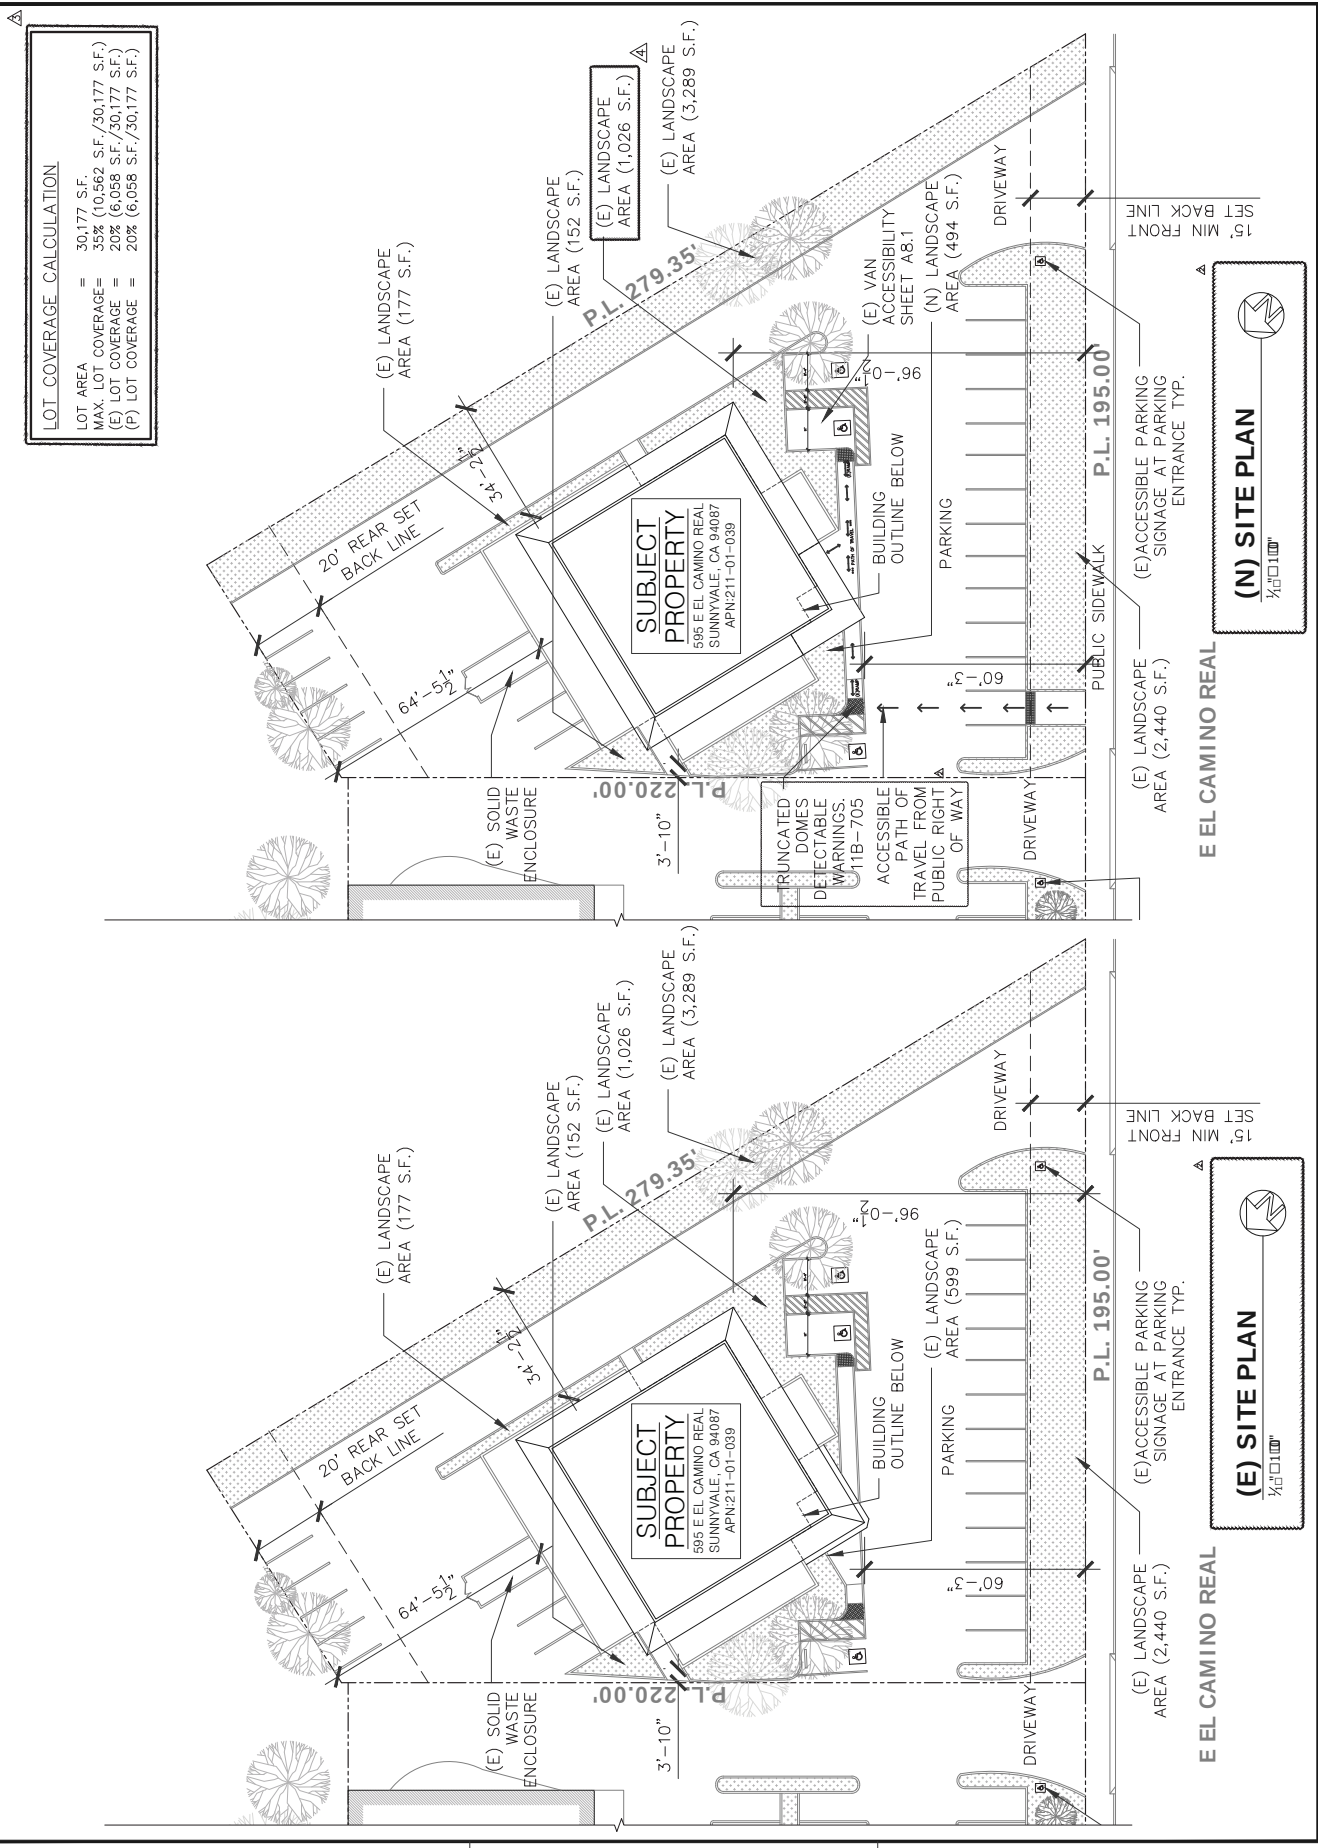

INNOVATIVE CONSULTING ENGINEER
APPLICANT:
ALLFO ON KOREA, LLC
595 E EL CAMINO REAL
SUNNYVALE, CA 94087
213.222.7413

SITE PLANS

PROJECT ADDRESS:
595 E EL CAMINO REAL
SUNNYVALE, CA 94087
APN: 211.01.039

PROJECT DESCRIPTION:
COMMERCIAL T.I.

PREPARED BY: TIEH CHAI
REVIEWED BY: JEFF CHOW
PHONE #: 650.741.6868


NOTES	BY	T.C.
△ 03072017 COMMENT		T.C.
△ 04072017 COMMENT		T.C.
△ 04212017 COMMENT		T.C.
△ 05122017 REVISION		T.C.
△		
△		


DATE: 11/2/2016
SCALE: AS NOTED
TITLE: T.C.
NO: 161002
SHEET:

A0.1
SHEETS OF

PRINT DATE: Nov 25, 2017 - 12:11pm

All plans, drawings, specifications and/or information furnished herewith are and shall remain the property of ICE DESIGN INC. and be held confidential and not be used for any purposes other than those for which they have been supplied and prepared these drawings are not to be copied or duplicated without ICE DESIGN INC.'s permission

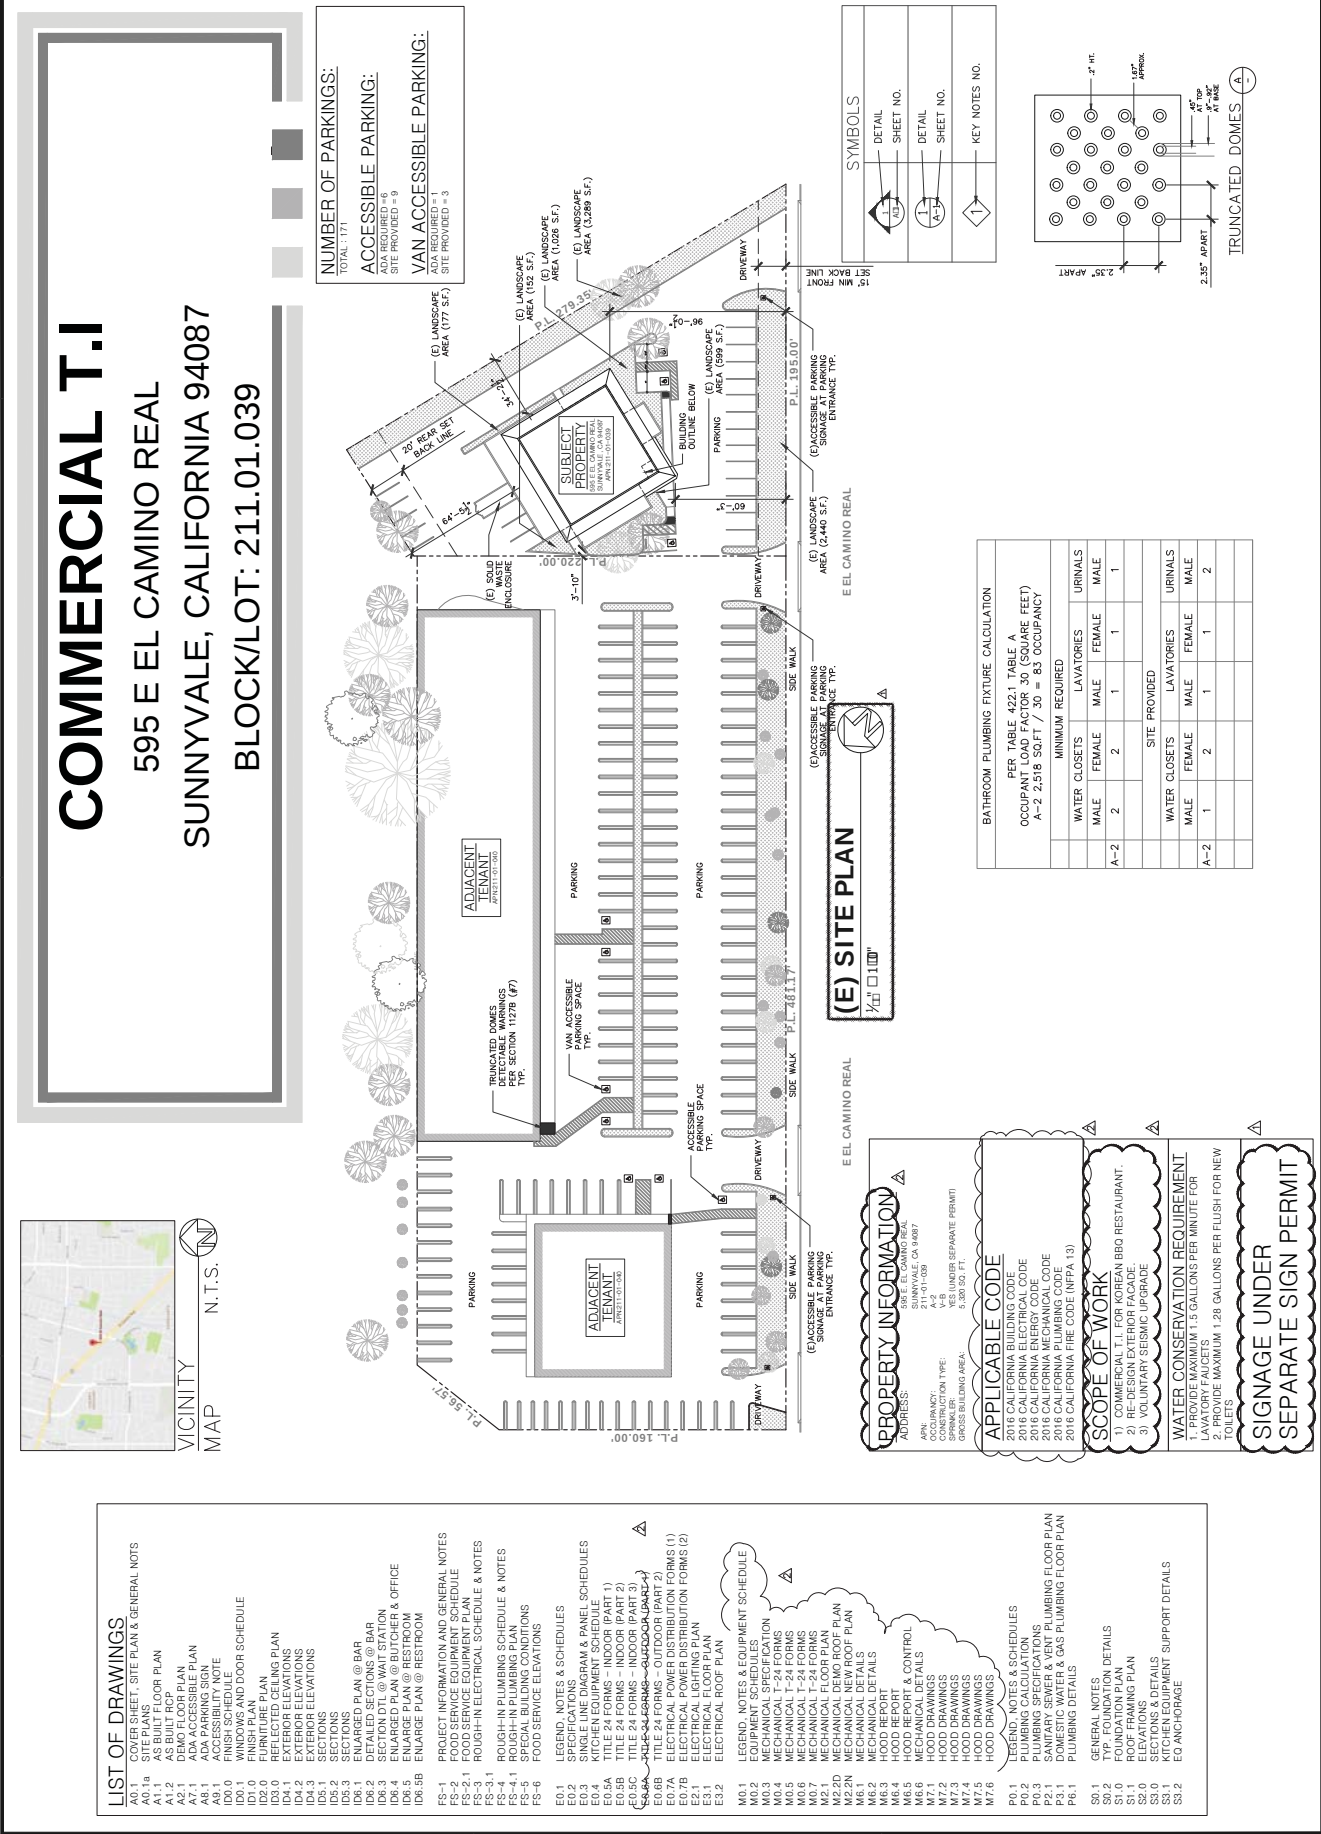

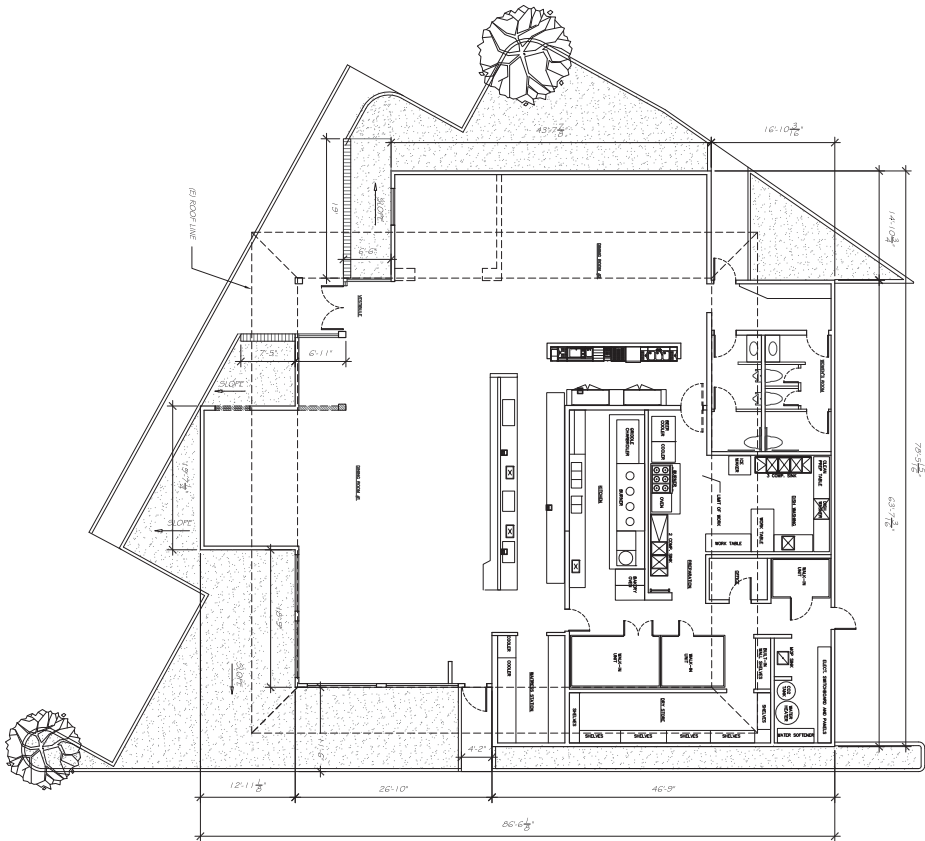

A
AS-BUILT PLAN
SCALE: 1/8" = 1'-0"

LEGEND
EXISTING WALL
NEW WALL
WALL TO BE REMOVED

DESIGNER:

PROJECT:

10 BUTCHERS
595 E EL CAMINO REAL
SUNNYVALE, CA 94087

THESE DRAWINGS ARE THE PROPERTY OF BKON INTERIOR SOLUTIONS. ANY REPRODUCTION OR USE OF THESE DRAWINGS WITHOUT THE WRITTEN PERMISSION OF BKON INTERIOR SOLUTIONS IS PROHIBITED. THESE DRAWINGS ARE FOR CONSTRUCTION OF PRODUCT SHIPPED BY BKON INTERIOR SOLUTION, AND ARE NOT TO BE USED (EXCEPT AS REFERENCED BY ANY OTHER DRAWING) FOR ANY OTHER PROJECT. THESE DOCUMENTS ARE OF A PROPRIETARY NATURE, ACT AGAINST BKON INTERIOR SOLUTION.

REVISIONS:

NO. DATE DESCRIPTION

DWG TITLE :

AS-BUILT PLAN

DWG NUMBER :

A 1.1



INNOVATIVE
CONSULTING
ENGINEER
APPLICANT:
ALFLO ON KOREA, LLC
595 E EL CAMINO REAL
SUNNYVALE, CA 94087
213.222.7413

SHEET TITLE:

FLOOR PLANS & NOTES


PROJECT ADDRESS:
595 E EL CAMINO REAL
SUNNYVALE, CA 94087
APN: 211.01.039
PROJECT DESCRIPTION:
COMMERCIAL T.I.

PREPARED BY: TENG CHU
REVIEWED BY: JEFF CHOW
DATE: 11/2/2016
PROJECT # : 6507-14.0565

NOTES	BY
03072017 COMMENT	T.C.
04072017 COMMENT	T.C.
0412017 COMMENT	T.C.
05122017 REVISION	T.C.
DATE	11/2/2016
SCALE	AS NOTED
DRAWN	T.C.
JOB	161002
SHEET	

100%
SHEETS

PRINT DATE: Nov. 08, 2017 - 2:30pm

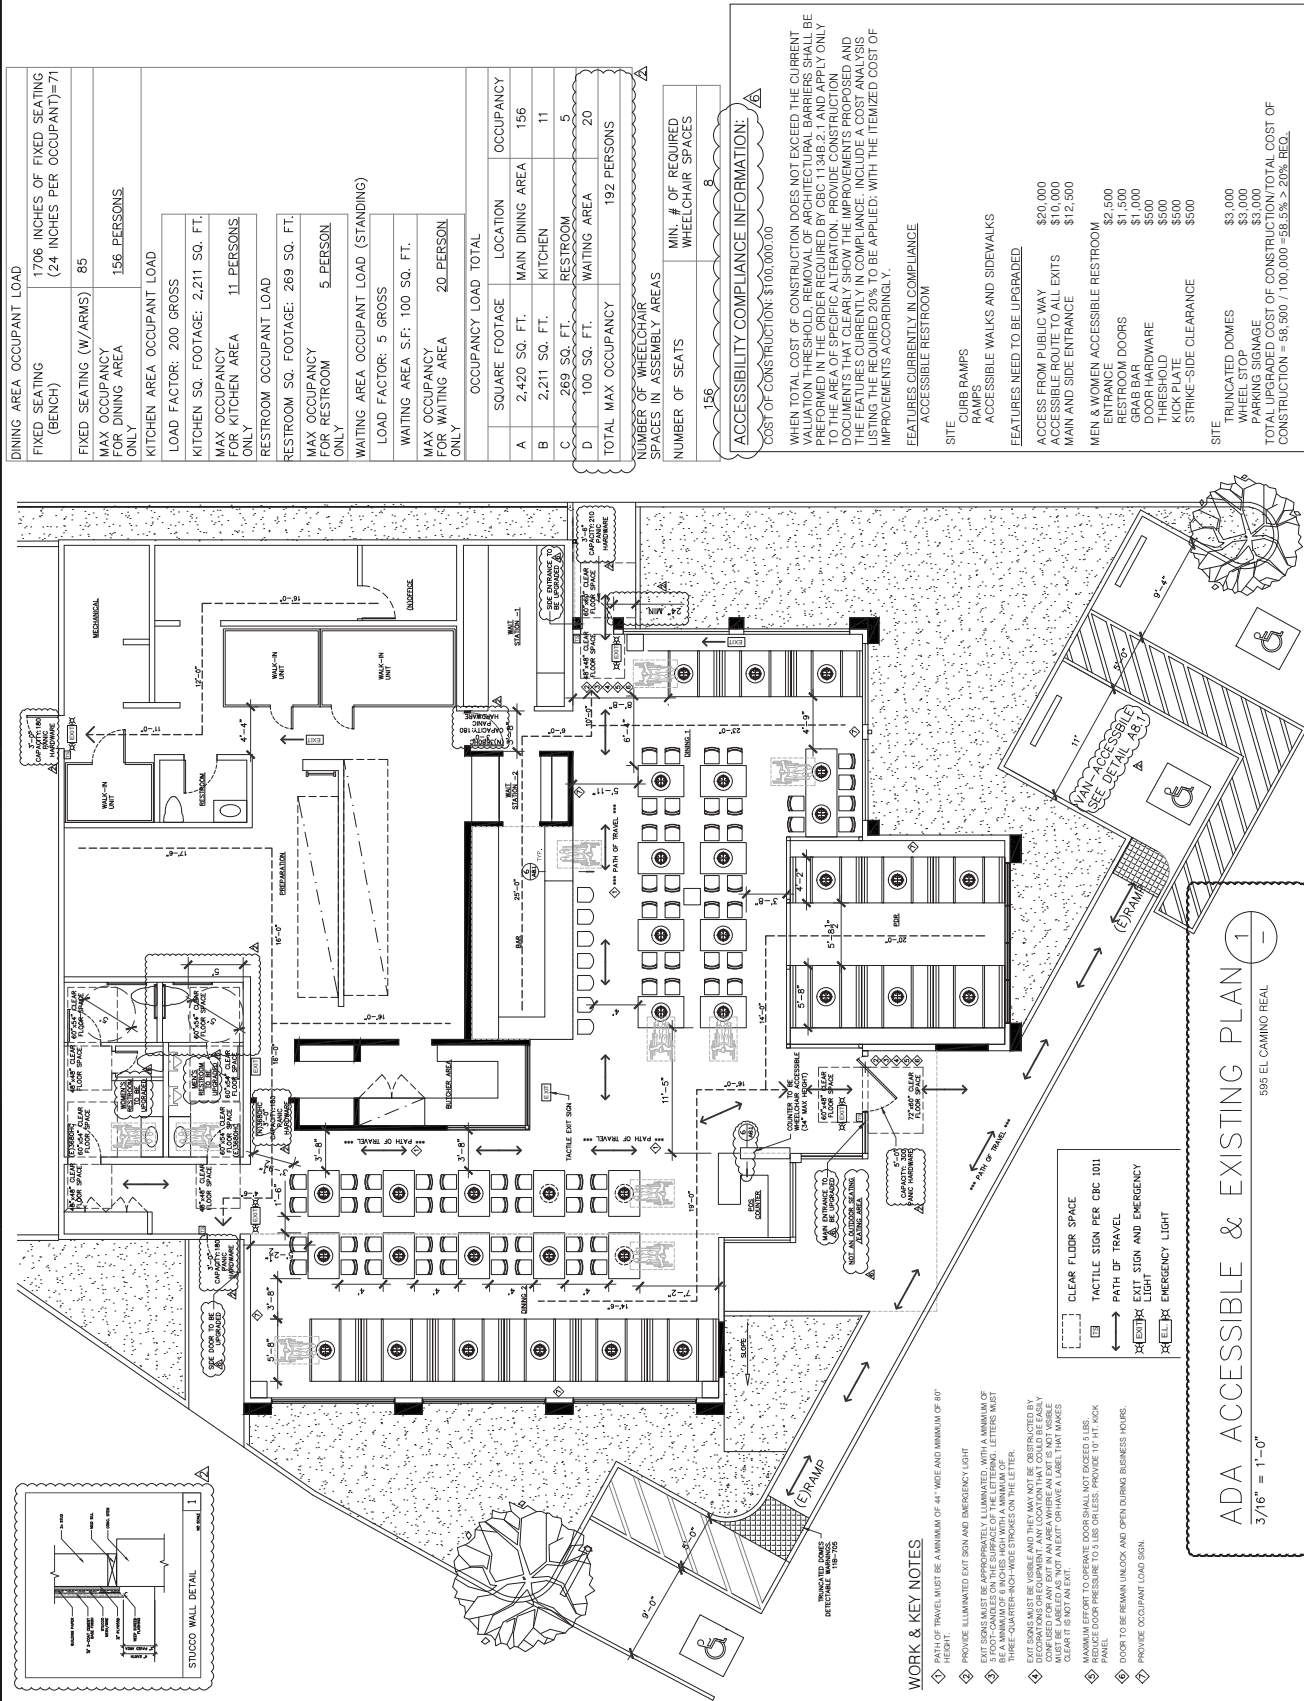

All plans, drawings, specifications and/or information furnished herewith are and shall remain the property of ICE DESIGN INC. and are not to be copied or duplicated without ICE DESIGN INC.'s permission. Any reuse, modification, or alteration of these drawings without the written consent of ICE DESIGN INC. is strictly prohibited.